
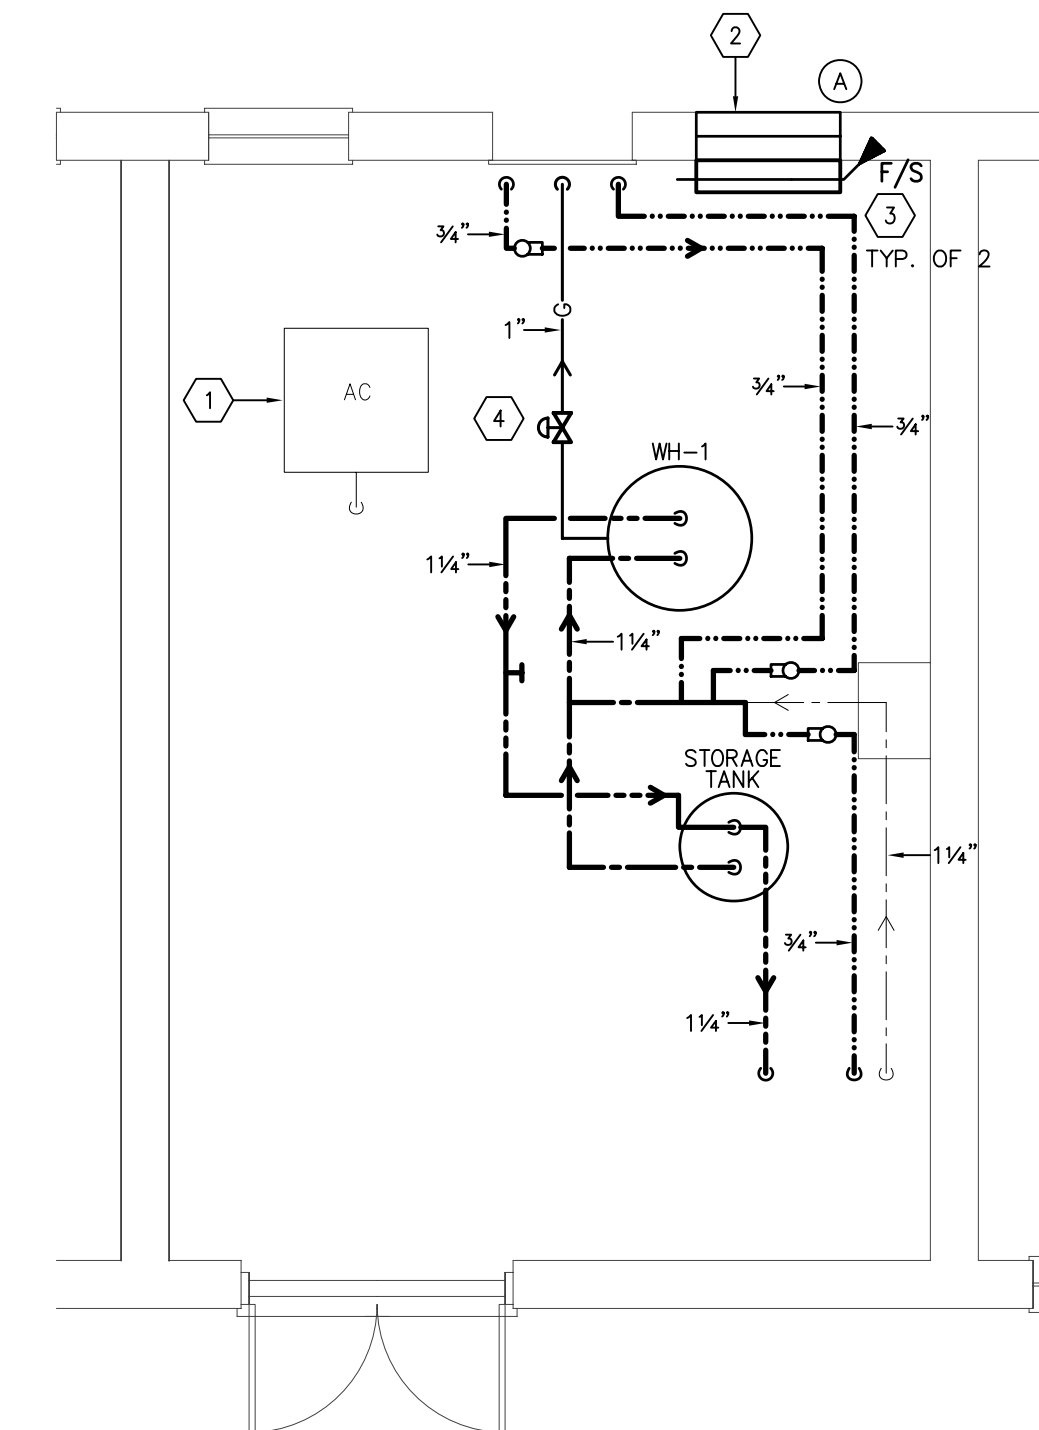


AIR DEVICE SCHEDULE							
MARK	FACE SIZE	NECK SIZE	MATERIAL	ACCESSORIES	FINISH	MANUFACTURER AND MODEL	NOTES
A	36X12	36X12	ALUMINUM	BIRDSCREEN	KYNAR	RUSKIN-ELF6375DXD	① ②
B	12X12	12X12	ALUMINUM	BIRDSCREEN	KYNAR	RUSKIN-ELF6375DXD	① ②
C	18X12	18X12	ALUMINUM	BIRDSCREEN	KYNAR	RUSKIN-ELF6375DXD	① ②

- NOTES:**
- COORDINATE LOUVER INSTALLATION TYPE WITH ARCHITECT BEFORE ORDERING LOUVER. IF THE "BOX FRAME" INSTALLATION TYPE IS SELECTED, THEN ADD THE OPTION FOR THE EXTENDED SILL. PROVIDE WITH SHEET METAL PLENUM 12 INCHES DEEP X FACE DIMENSION FOR TRANSITION OF LOUVER TO DUCT.
  - RATED FOR 130 MPH WINDS AND IMPACT RESISTANT. ASSEMBLE ACCORDING TO MANUFACTURER INSTRUCTIONS TO MAINTAIN RATING.

- KEYED NOTES**
- EXISTING AC UNIT TO REMAIN.
  - PROVIDE TWO LOUVERS IN EXTERIOR WALL. EACH LOUVER SHALL HAVE A MINIMUM OF 1.0 SQUARE FEET OF FREE AREA. PROVIDE ONE LOUVER WITHIN 12" OF TOP OF ROOM AND ONE LOUVER WITHIN 12" OF BOTTOM OF ROOM.
  - PROVIDE OUT OF WALL COMBINATION FIRE/SMOKE DAMPER AND SLEEVE REQUIRED TO MAINTAIN 1 HOUR RATED WALL CONDITION. FIRE/SMOKE DAMPER SHALL HAVE 120VOLT SINGLE PHASE ACTUATOR AND SHALL BE CONNECTED TO CENTRAL FIRE ALARM SYSTEM TO CLOSE UPON ACTUATION OF SMOKE DETECTOR WITHIN ROOM.
  - PROVIDE AUTOMATIC GAS SHUT DOWN VALVE WITH MANUAL RESET. GAS VALVE SHALL BE CONNECTED TO CENTRAL FIRE ALARM SYSTEM AND SHALL CLOSE UPON ACTUATION OF SYSTEM. COORDINATE ACTUATOR VOLTAGE WITH FIRE ALARM CONTRACTOR.

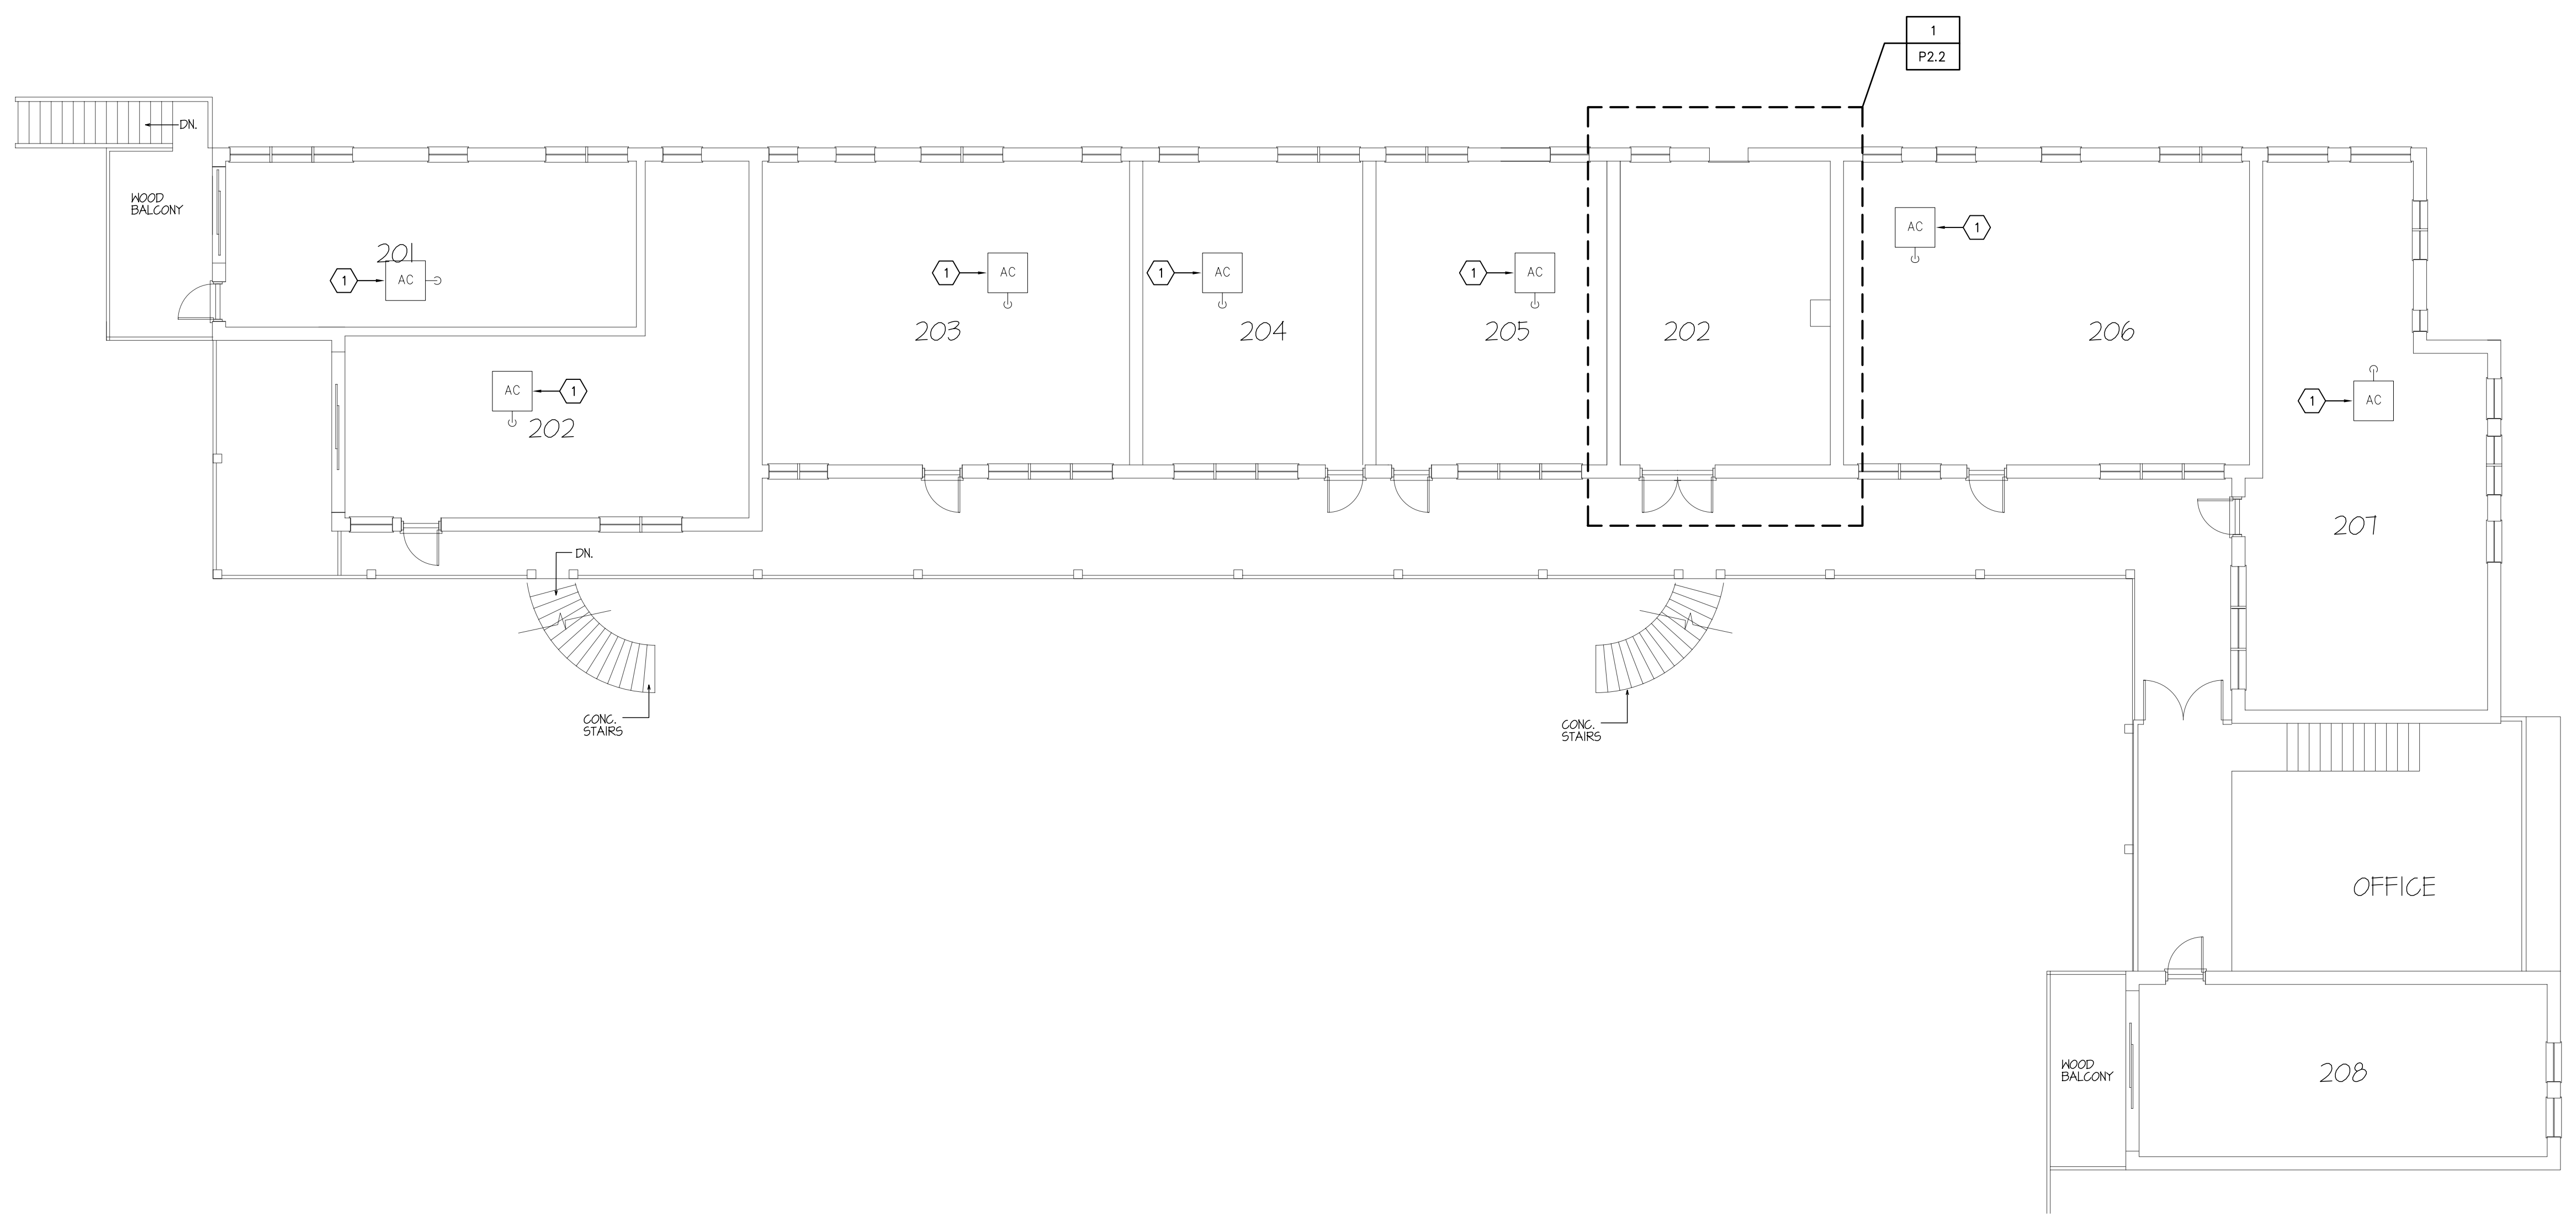

**1 ENLARGED PLAN RM. 202**  
 P2.2 SCALE: 1/4" = 1'-0"

**NOTE:**  
 ALL HOT WATER PIPING AND RECIRCULATING WATER PIPING WITHIN THIS ROOM SHALL BE PROVIDED WITH NEW INSULATION. REFER TO SPECS FOR ADDITIONAL INFORMATION. HOT WATER AND RECIRCULATING WATER PIPING HAS BEEN SHOWN IN BOLD ON ENLARGED PLAN.

NO.	DATE	REVISIONS	COMMENTS

**RENOVATION/RESTORATION PROJECT**  
**MARINER BEACH CLUB**  
 4220 GULF BOULEVARD  
 ST. PETERSBURG BEACH, FLORIDA 33706

**billerreinhardt**  
 STRUCTURAL GROUP, INC.  
 4014 gulf highway suite 248, tampa, florida 33618  
 telephone : 813.908.7203 fax: 813.908.7303  
 email : info@billerreinhardt.com  
 State of Florida Certificate of Authorization No. 9149

USE THE SET OF THE PLANS, SPECIFICATIONS, CONTRACT AND THE PLANS AND SPECIFICATIONS COMPLY WITH THE APPLICABLE NATIONAL BUILDING CODES

**NORTH BUILDING SECOND FLOOR PLUMBING PLAN**  
 DATE: 02-23-09 DRAWN BY: CSR  
 JOB NO: 08-132 DESIGN BY: OFB

SHEET NO.  
**MP2.2**