


MARINER BEACH CLUB

RENOVATION / RESTORATION PROJECT

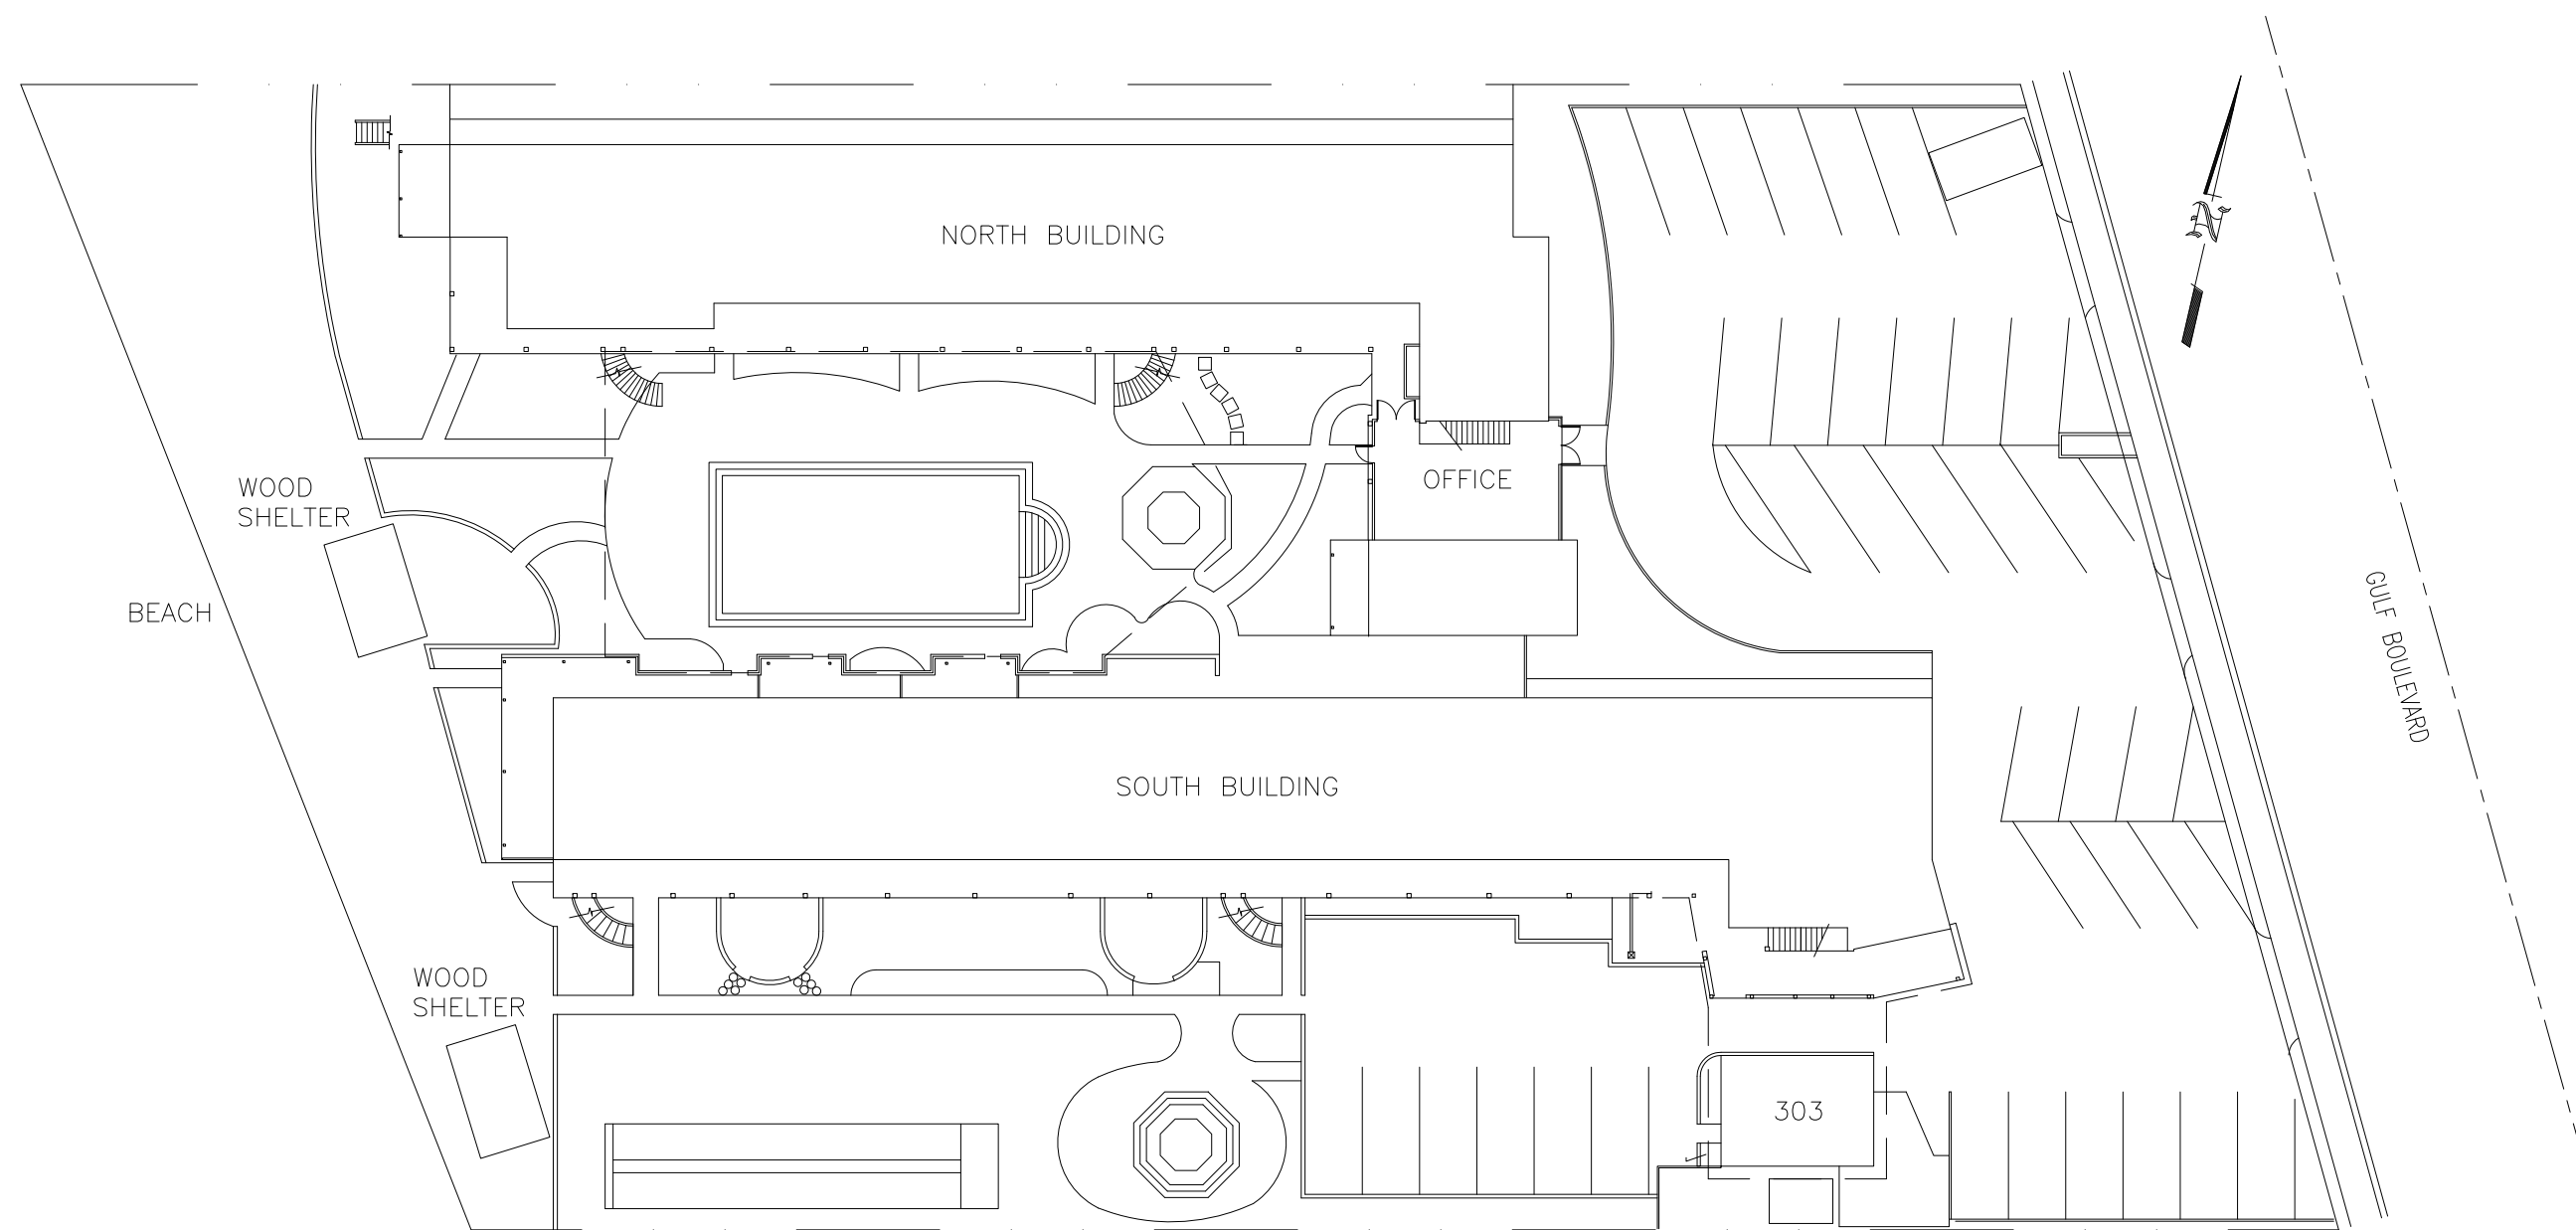

MARINER BEACH CLUB
 4220 GULF BOULEVARD
 ST. PETERSBURG BEACH, FLORIDA 33706

ISSUE DATE:
 FEBRUARY 23, 2009

REVISIONS		COMMENTS
NO.	DATE	

RENOVATION/RESTORATION PROJECT
MARINER BEACH CLUB
 4220 GULF BOULEVARD
 ST. PETERSBURG BEACH, FLORIDA 33706

billerreinhart
 STRUCTURAL GROUP, INC.
 4014 gum highway suite 248, tampa, florida 33618
 telephone : 813.908.7203 fax : 813.908.7303
 email : info@billerreinhart.com
 State of Florida Certificate of Authorization No. 9149

FOR THE BEST OF THE PROJECT, ALL WORK SHALL BE DONE IN ACCORDANCE WITH THE PLANS AND SPECIFICATIONS COMPANY WITH THE APPLICABLE FEDERAL AND LOCAL CODES.

MICHAEL H. BILLER
 FL. P.E. NO. 499772

COVER SHEET

DATE: 2-23-09 DRAWN BY: RC
 JOB NO: 08-132 DESIGN BY: MB/CP/LL

SHEET NO.
S0.0

STRUCTURAL DRAWING INDEX	
S0.0	COVER SHEET
S1.0	GENERAL STRUCTURAL NOTES
S1.1	GENERAL STRUCTURAL NOTES & WINDOW/DOOR SCHEDULES
S1.2	WINDOW/DOOR/HARDWARE SCHEDULES
S2.0	SITE PLAN
S3.0	NORTH BUILDING 1ST FLOOR
S3.1	NORTH BUILDING 2ND FLOOR
S3.2	SOUTH BUILDING 1ST FLOOR
S3.3	SOUTH BUILDING 2ND FLOOR
S4.0	REPAIR DETAILS
S4.1	SECTION AND DETAILS
S4.2	SECTION AND DETAILS
S4.3	SECTION AND DETAILS
S4.4	SHELTER PLANS AND DETAILS
S4.5	STAIR PLANS, SECTIONS AND DETAILS
S4.6	STAIR PLANS, SECTIONS AND DETAILS

ELECTRICAL DRAWING INDEX	
E0.0	ELECTRICAL LEGEND
E2.0	ELECTRICAL SITE PLAN
E2.1	NORTH BUILDING 1ST FLOOR ELECTRICAL PLAN
E2.2	NORTH BUILDING 2ND FLOOR ELECTRICAL PLAN
E2.3	SOUTH BUILDING 1ST FLOOR ELECTRICAL PLAN
E2.4	SOUTH BUILDING 2ND FLOOR ELECTRICAL PLAN
E3.1	ELECTRICAL SINGLE LINE DIAGRAMS
E3.2	ELECTRICAL SINGLE LINE DIAGRAMS
E4.1	ELECTRICAL PANEL SCHEDULES

PLUMBING DRAWING INDEX	
P0.0	PLUMBING LEGEND
MP2.1	NORTH BUILDING 1ST FLOOR PLUMBING PLAN
MP2.2	NORTH BUILDING 2ND FLOOR PLUMBING PLAN
MP2.3	SOUTH BUILDING 1ST FLOOR PLUMBING PLAN
MP2.4	SOUTH BUILDING 2ND FLOOR PLUMBING PLAN